



GENERAL CEILING NOTES:

1. CONTRACTOR SHALL FOLLOW GRID PATTERN ESTABLISHED ON THE REFLECTED CEILING PLAN. ESTABLISHED ON THE REFLECTED CEILING PLAN. ANY VARIATIONS SHALL BE APPROVED BY THE ARCHITECT.
2. CEILING TILE TYPE AS SPECIFIED. CEILING HEIGHTS NOTED ON REFLECTED CEILING PLANS. CEILING ELEVATIONS ARE FROM THAT ROOM'S FINISH FLOOR.
3. WIRE CEILING FROM STRUCTURE ABOVE AND WIRE FOR ADDITIONAL LOAD AT LIGHTS AND CEILING DIFFUSERS.
4. UNLESS OTHERWISE NOTED, CEILING TO BE SUSPENDED METAL TEE AND ACoustICAL TILE 2'-0" x 2'-0" OR 2'-0" x 4'-0" TYPICAL. SEE SPECIFICATIONS FOR MANUFACTURER AND STYLE.
5. PENDANT MOUNTED FIXTURES CENTERED ON GRID REQUIRE GRID TO BE CUT AND SUPPORTED ON EACH SIDE.
6. MOUNT SPEAKERS AND SUPPLY AIR DIFFUSERS IN THE CENTER OF WHOLE CEILING PANELS. ADHERE A RIGID PANEL BACKER TO PANELS AT LOCATIONS WHICH INDICATE SPEAKERS, DIFFUSERS, LIGHTS, SMOKE DETECTORS, EXIT LIGHTS AND FIRE PROTECTION SMOKELESS.
7. PROVIDE 2" CEILING GRID CROSS-TEE AT EACH RETURN AIR GRILLE.
8. PROVIDE AN ADDITIONAL CROSS-TEE AT EACH SLOT DIFFUSER.
9. REFER TO THE MECHANICAL DRAWINGS FOR LOUVERS REQUIRED TO BE FRAMED IN CORNER BOARD BULKHEADS.
10. ALL CEILING HEIGHTS ARE SUBJECT TO CHANGE TO ACCOMMODATE UNFORSEEN FIELD CONDITIONS - COORDINATE CHANGES WITH ARCHITECT & RECTIFIED DISCIPLINES.
11. SOME CORRIDOR CEILING PANEL LAYOUTS HAVE BEEN ADJUSTED AT A CHANGE IN CORRIDOR DIRECTION TO ACCOMMODATE LIGHTING LAYOUT.

CEILING LEGEND	
	DIRECT EXTERIOR FINISH SYSTEM
	GYP-SUM BOARD CEILING
	PRE FINISHED VENTED METAL SOFFIT
	RECESSED 2x4 LIGHT FIXTURE
	RECESSED 1x4 LIGHT FIXTURE
	RECESSED LIGHT FIXTURE
	SURFACE / PENDANT MOUNT FIXTURE
	PENDANT MOUNT FIXTURE
	SURFACE MOUNT FIXTURE
	FIXTURE IS DESIGNATED FOR EMERGENCY OPERATION
	SINGLE FACE EXIT SIGN
	DOUBLE FACE EXIT SIGN
	WALL MOUNTED EXIT SIGN
	OCCUPANCY SENSOR
	FIRE ALARM - VISUAL
	FIRE ALARM - AUDIOVISUAL
	ALUMINUM SOFFIT
	PA SPEAKER
	SMOKE DETECTOR
	SUPPLY GRILLE / DIFFUSER
	RETURN GRILLE / DIFFUSER
	SLOT DIFFUSER
	MECHANICAL EQUIPMENT
	ACCESS DOOR
	CONTINUOUS SOFFIT VENT
	SOFFIT GRILLE (8x16 U.O.N.)
	C.J.
	CUT TILE

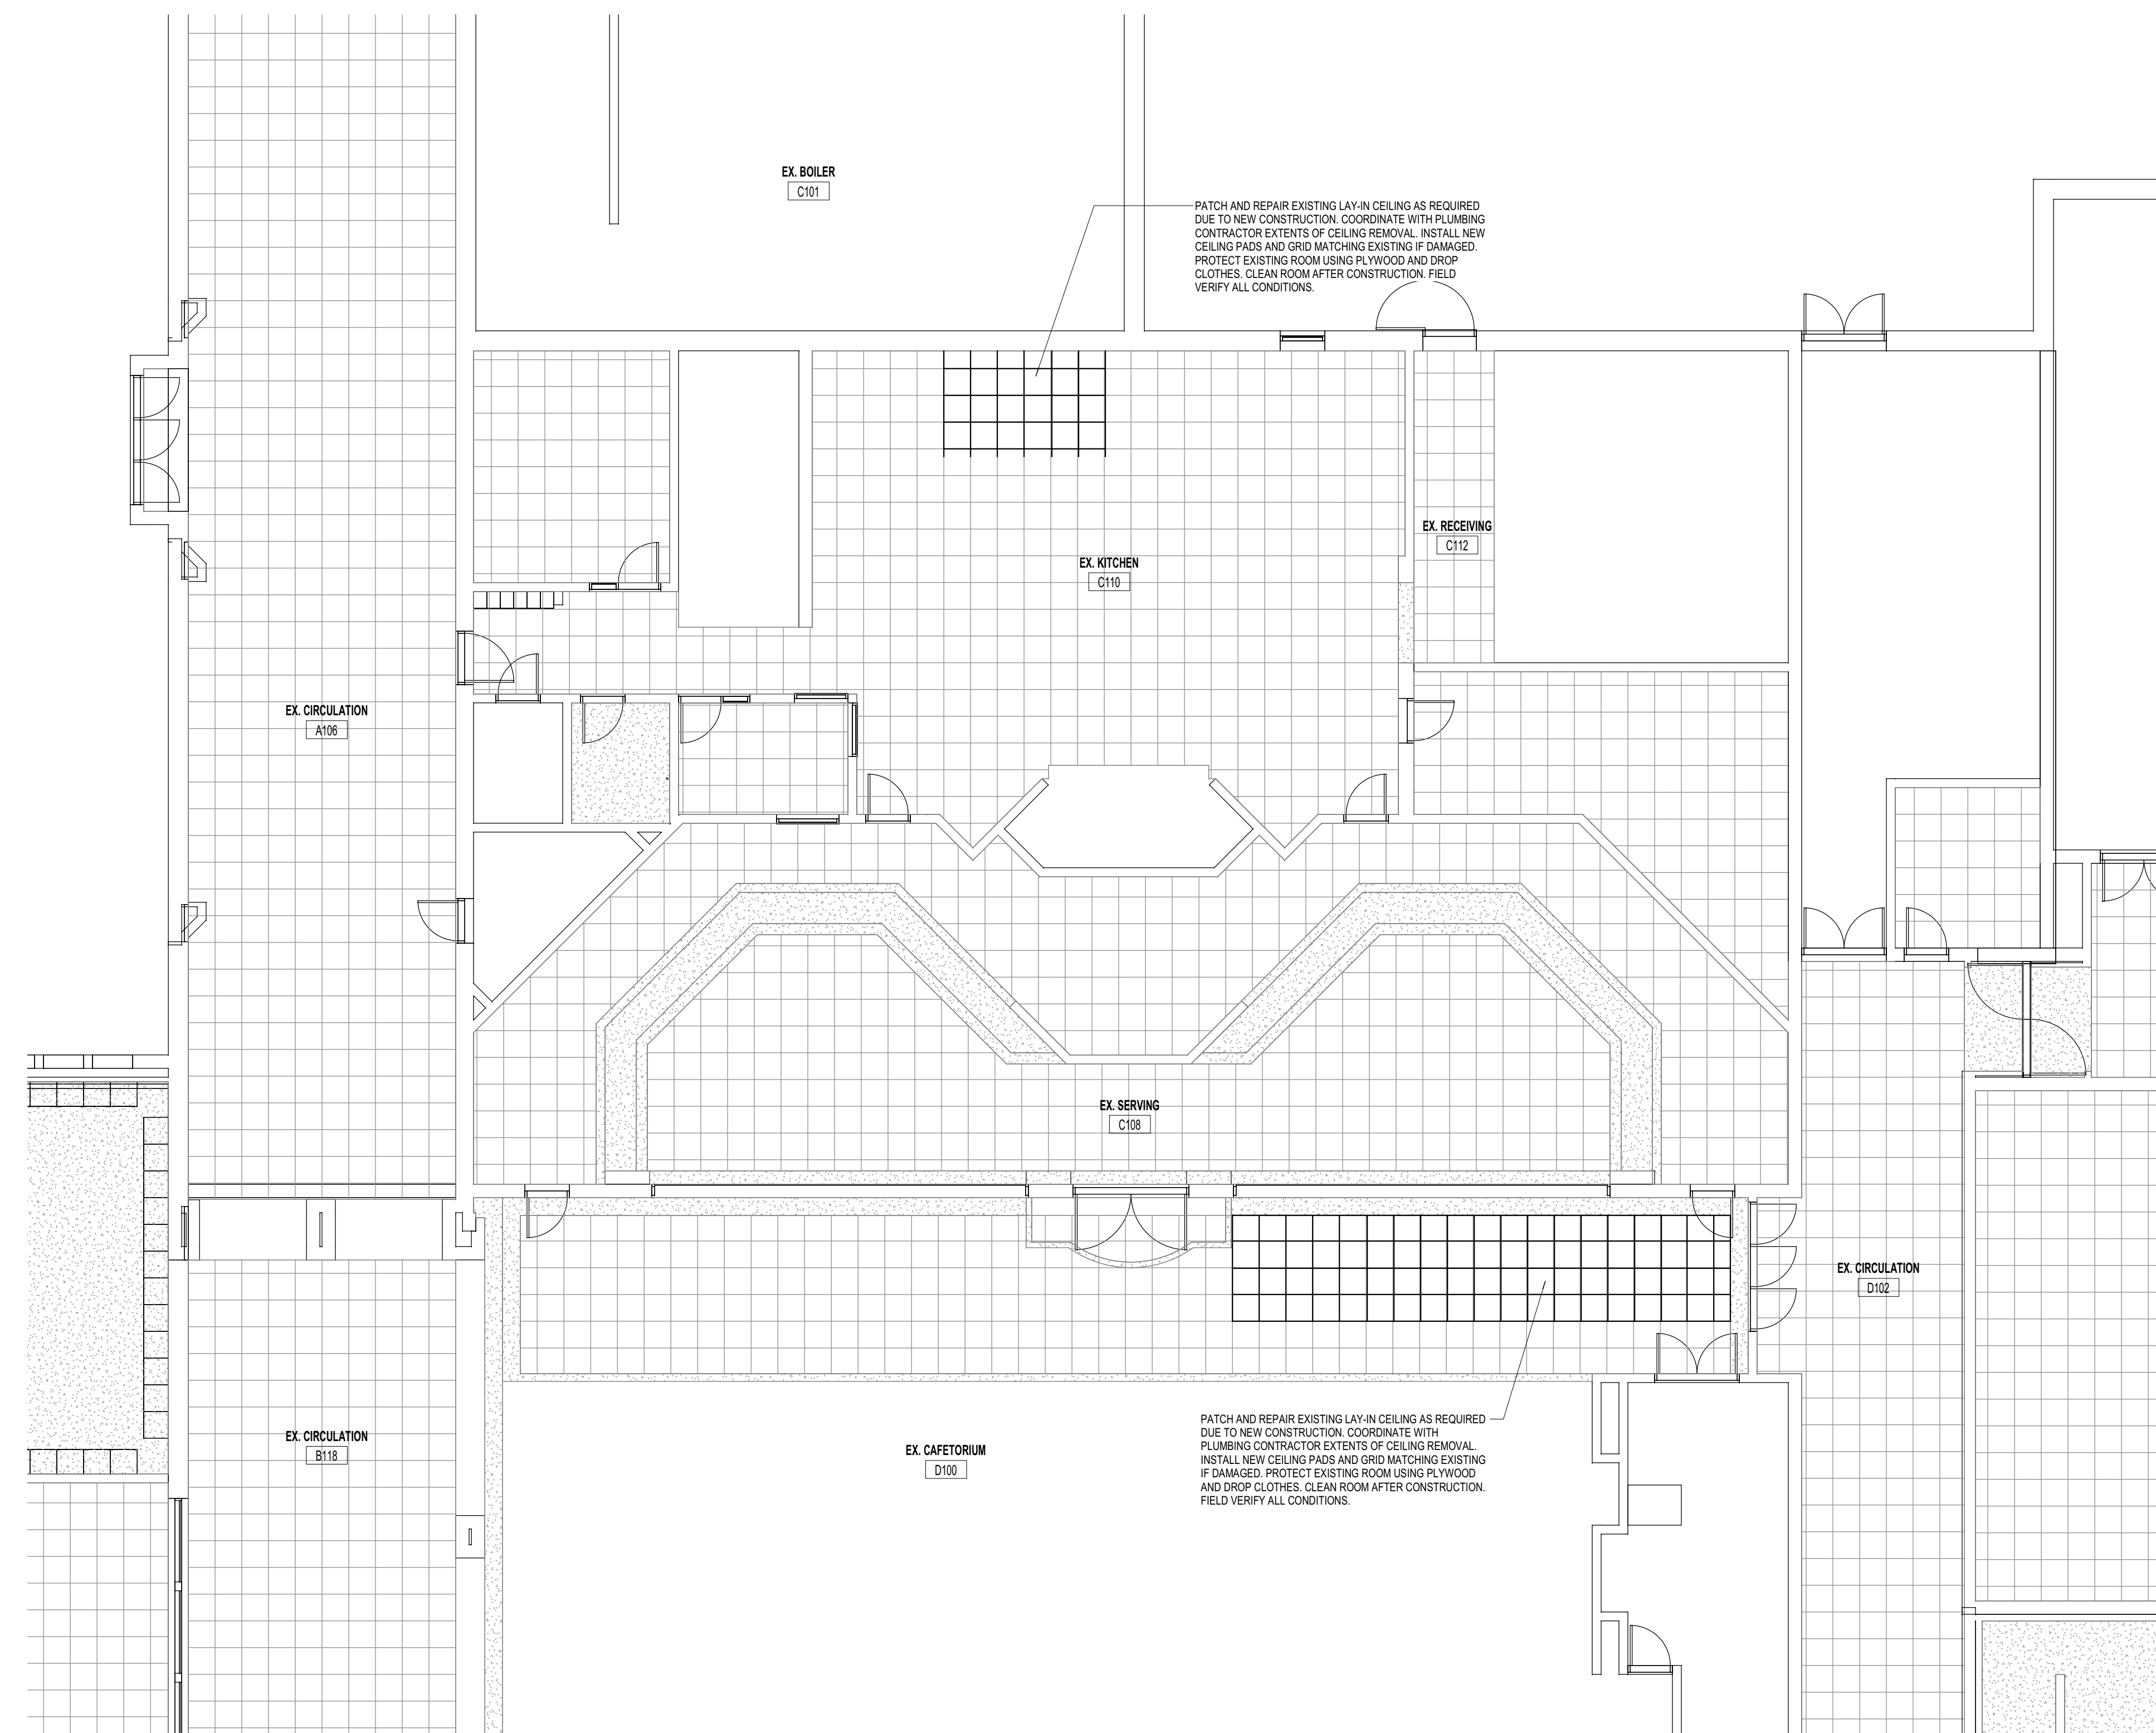

PARTIAL FIRST FLOOR REFLECTED CEILING PLAN
1/8" = 1'-0"

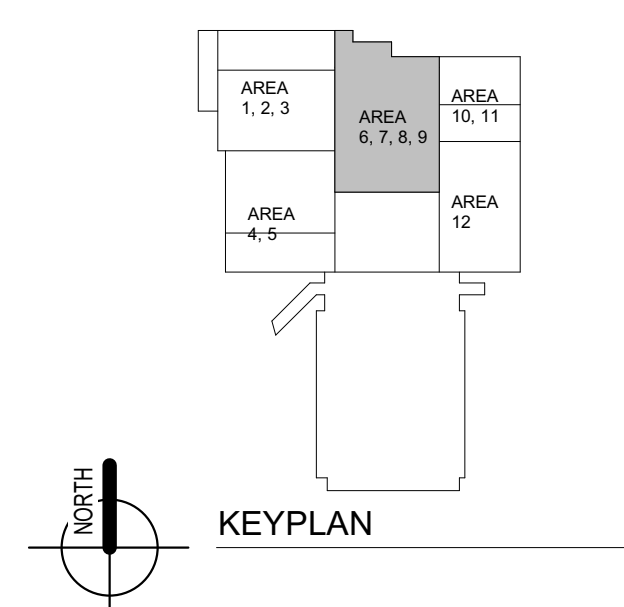

SOUTH HIGH SCHOOL PARTIAL RE-ROOF
WEST OTTAWA PUBLIC SCHOOLS
 HOLLAND, MICHIGAN

ISSUANCES
03/20/2020 BIDS & CONSTRUCTION

DRAWN SK
REVIEWED LM

PROJECT NO. 5-4876

No part of this drawing may be used or reproduced in any form or by any means, or stored in a database or retrieval system, without prior written permission of

GMB Copyright © 2020
All Rights Reserved

PARTIAL FIRST FLOOR
REFLECTED CEILING PLAN

A3.1A